


EQUIPMENT SCHEDULE

NO. QTY.	SUPPLY	INSTALL	DESCRIPTION	MANUFACTURER & MODEL NO.	SIZE	PLUMBING			ELECTRICAL	REMARKS
						WASTE	COOL.	HOT VENT GAS		
1	OWNER	OWNER'S	12 GAL. KETTLE	CLARENDON 140-0-068	27" W x 27" D				200V, 27 A, 3W	GENERAL CONTRACTOR TO PROVIDE GENERAL POWER CONNECTION.
2	OWNER	OWNER'S	(2) BURNER RANGE W/ CONVECTION OVEN	FRIGIDAIRE 36" W x 24" D	36" W x 24" D				120V, 60HZ, 1/4HP	GENERAL CONTRACTOR TO PROVIDE GENERAL POWER CONNECTION.
3	OWNER	OWNER'S	COFFEE MAKER	SHARP SMC-6048	46" W x 25" D x 18" H				115V, 3A, 1/8HP	GENERAL CONTRACTOR TO PROVIDE GENERAL POWER & PLUMBING CONNECTIONS.
4	OWNER	OWNER'S	SLAUGHTER BROILER	WHEELER S26-0-066	30" W x 23" D				120V, 1#	GENERAL CONTRACTOR TO PROVIDE GENERAL POWER CONNECTION.
5	OWNER	OWNER'S	CHEF BASE	TRUE TRUE 420-110-1-N	42" W x 24" D				120V, 1#	GENERAL CONTRACTOR TO PROVIDE GENERAL POWER CONNECTION.
6	OWNER	OWNER'S	GRIDDLE W/ (2) STANDARD OVEN & (2) BURNERS	326-0-018	48" W x 34" D x 36" H				120V, 1#	GENERAL CONTRACTOR TO PROVIDE GENERAL POWER CONNECTION.
7	OWNER	OWNER'S	50 LBS. FRYER	PICO FRYER 42-50 LBS. FRYER	18" W x 22" W x 16" H				120V	GENERAL CONTRACTOR TO PROVIDE GENERAL POWER CONNECTION.
8	OWNER	OWNER'S	EXHAUST HOOD							
9	OWNER	OWNER'S	FRESH AIR SUPPLY FAN							
10	OWNER	OWNER'S	EXHAUST FANS							
11	OWNER	OWNER'S	FIRE SUPPRESSION SYSTEM							
12	OWNER	OWNER'S	SANDWICH PREP	BEI-48 082-4-418-1D	30" W x 27" D				1/4 HP	GENERAL CONTRACTOR TO PROVIDE GENERAL POWER CONNECTION.
13	OWNER	OWNER'S	STAINLESS STEEL SHELVING	ZESCO 012-0-278	48" W x 15" D					W/MOUNTING BRACKETS
14	OWNER	OWNER'S	STAINLESS STEEL SHELVING	ADVANCE TABCO 012-0-268	48" W x 15" D					W/MOUNTING BRACKETS
15	OWNER	OWNER'S	STAINLESS STEEL SHELVING	ADVANCE TABCO 012-0-268	48" W x 15" D					W/MOUNTING BRACKETS
16	OWNER	OWNER'S	STAINLESS STEEL SHELVING	ADVANCE TABCO 012-0-268	48" W x 15" D					W/MOUNTING BRACKETS
17	OWNER	OWNER'S	HOT TABLE	ADVANCE TABCO 012-0-148 W/V BROSBUACH	120" W x 120" D					GENERAL CONTRACTOR TO PROVIDE GENERAL POWER CONNECTION.
18	OWNER	OWNER'S	WATNESS POK-UP AREA	ADVANCE TABCO 012-0-148 W/V BROSBUACH	120" W x 20" D					GENERAL CONTRACTOR TO PROVIDE GENERAL POWER CONNECTION.
19	OWNER	OWNER'S	MARSHALL	ZESCO 012-0-022	15" W x 17" D				120V, 20A	GENERAL CONTRACTOR TO PROVIDE GENERAL POWER CONNECTION.
20	OWNER	OWNER'S	HANGSINK	ADVANCE TABCO 012-0-022	15" W x 17" D				120V	GENERAL CONTRACTOR TO PROVIDE GENERAL POWER CONNECTION.
21	OWNER	OWNER'S	TROUSER CAN							4" CENTERS, GORSENER, WALL MOUNT
22	OWNER	OWNER'S	SHELVING							
23	OWNER	OWNER'S	WOOD WALK-IN COOLER	420-4-007	81" W x 118" D x 88" H				115V, 60HZ, 1#	GENERAL CONTRACTOR TO PROVIDE GENERAL POWER CONNECTION.
24	OWNER	OWNER'S	WOOD WALK-IN FREEZER	420-4-018	81" W x 118" D x 88" H				115V, 60HZ, 1#	GENERAL CONTRACTOR TO PROVIDE GENERAL POWER CONNECTION.
25	OWNER	OWNER'S	SLICER	ADVANCE TABCO 012-0-181	18" W x 16" D x 16" H				120V, 60HZ, 1#	GENERAL CONTRACTOR TO PROVIDE GENERAL POWER CONNECTION.
26	OWNER	OWNER'S	WONDER COUNTERTOP	ZESCO 012-0-190	60" W x 18" D				120V, 7A	GENERAL CONTRACTOR TO PROVIDE GENERAL POWER CONNECTION.
27	OWNER	OWNER'S	STAINLESS STEEL WALL SHELF	ZESCO 012-0-329	72" W x 12" D					8" CENTERS, WALL MOUNTED
28	OWNER	OWNER'S	WALL MOUNT	ZESCO 012-0-016	30" W x 28" D					
29	OWNER	OWNER'S	DISPENSER	N-SINK-GRABER 332-0-015-1D	15" W x 14" H					COMPLETE WITH SINK FLANGE
30	OWNER	OWNER'S	STAINLESS STEEL SOLED DISH	ADVANCE TABCO 012-0-014	28" W x 17" D				200/230V, 30.9A	GENERAL CONTRACTOR TO PROVIDE GENERAL POWER CONNECTION.
31	OWNER	OWNER'S	STAINLESS STEEL FOR CUPS/DISS RACK	ADVANCE TABCO 012-0-014	28" W x 17" D				14"	GENERAL CONTRACTOR TO PROVIDE GENERAL POWER CONNECTION.
32	OWNER	OWNER'S	CORNER DISHWASHER	HUBBART 306-0-044	36" W x 30" D				3P	GENERAL CONTRACTOR TO PROVIDE GENERAL POWER CONNECTION.
33	OWNER	OWNER'S	CONDENSATION HOOD / DISHWASHER CANYON	ZESCO 350-0-075	22" W x 27" D					FLOOR LINT
34	OWNER	OWNER'S	50 GAL. INTERPHONE	3M-0-111	22" W x 27" D					
35	OWNER	OWNER'S	STAINLESS STEEL CLEAN DISH	ADVANCE TABCO 012-0-350	60" W x 18" D					GENERAL CONTRACTOR TO PROVIDE GENERAL POWER & PLUMBING CONNECTIONS.
36	OWNER	OWNER'S	ICE MAKER & BIN	MANITOWOC 4-015 012-0-350	36" W x 30" D				60 HZ, 1#	GENERAL CONTRACTOR TO PROVIDE GENERAL POWER & PLUMBING CONNECTIONS.
37	OWNER	OWNER'S	2 DOOR REFRIG. & COMP. UNIT	BEVAGE-AIR 082-4-280	34" W x 23" D x 31" H				115V, 4A, 1/8 HP	GENERAL CONTRACTOR TO PROVIDE GENERAL POWER CONNECTION.
38	OWNER	OWNER'S	COFFEE MAKER	BLUN 111-0-017	18" W x 12" D x 20" H				120V	GENERAL CONTRACTOR TO PROVIDE GENERAL POWER & PLUMBING CONNECTIONS.
39	OWNER	OWNER'S	REPRESENTATIVE	BEVAGE-AIR 082-4-280	34" W x 23" D x 31" H				115V, 4A, 1/8 HP	GENERAL CONTRACTOR TO PROVIDE GENERAL POWER CONNECTION.
40	OWNER	OWNER'S	COFFEE MAKER	BLUN 111-0-017	18" W x 12" D x 20" H				120V	GENERAL CONTRACTOR TO PROVIDE GENERAL POWER & PLUMBING CONNECTIONS.
41	OWNER	OWNER'S	TRASH CAN							BRAN TO FLOOR SINK
42	OWNER	OWNER'S	FLUIDE GLASS WASHER	PERLUX 55-0-046	24" W x 24" D x 28" H				120V, 6.7A, 60HZ	GENERAL CONTRACTOR TO PROVIDE GENERAL POWER & PLUMBING CONNECTIONS.
43	OWNER	OWNER'S	3 TUB SINK	ZESCO 754-0-033	22" W x 21" D					4" CENTERS, DECK MOUNT

EQUIPMENT SCHEDULE


NO. QTY.	SUPPLY	INSTALL	DESCRIPTION	MANUFACTURER & MODEL NO.	SIZE	PLUMBING			ELECTRICAL	REMARKS
						WASTE	COOL.	HOT VENT GAS		
43	OWNER	OWNER'S	SHIELDING							
44	OWNER	OWNER'S	GLASS WASHER	HAMILTON BECH 288-0-058	11" W x 17" D x 18" H				120V, 60HZ, 1/4HP	GENERAL CONTRACTOR TO PROVIDE GENERAL POWER CONNECTION.
45	OWNER	OWNER'S	CONDIMENT REFRIGERATOR	GEORGES AIR 277" x 27" D x 39" H	27" W x 27" D x 39" H				115V, 3A, 1/8HP	GENERAL CONTRACTOR TO PROVIDE GENERAL POWER & PLUMBING CONNECTIONS.
46	OWNER	OWNER'S	ESPRESSO MACHINE	DE'LONGHI MAC CH V					1/2"	GENERAL CONTRACTOR TO PROVIDE GENERAL POWER CONNECTION.
47	OWNER	OWNER'S	GRINDER						120V	GENERAL CONTRACTOR TO PROVIDE GENERAL POWER CONNECTION.
48	OWNER	OWNER'S	WINE REFRIGERATOR	AAMTI	30" W				120V	GENERAL CONTRACTOR TO PROVIDE GENERAL POWER CONNECTION.
49	OWNER	OWNER'S	POS						120V	GENERAL CONTRACTOR TO PROVIDE GENERAL POWER CONNECTION.
50	OWNER	OWNER'S	SHIELDING							
51	OWNER	OWNER'S	STEREO CABINET		30" W x 24" D				120V	GENERAL CONTRACTOR TO PROVIDE GENERAL POWER CONNECTION.

NOTE:
01. GENERAL CONTRACTOR TO VERIFY ALL PLUMBING, GAS, AND ELECTRICAL REQUIREMENTS WITH OWNER PRIOR TO INSTALLATION.

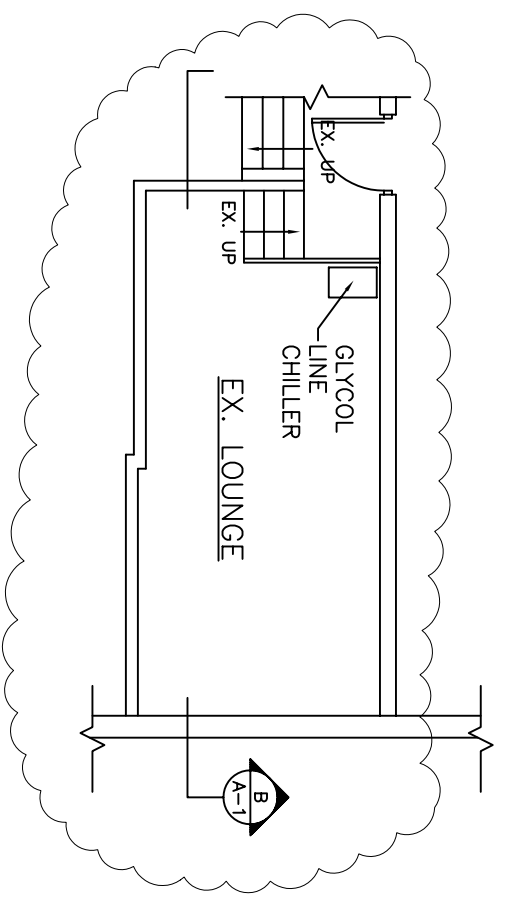

PROPOSED EQUIPMENT FLOOR PLAN

SCALE: 1/8" = 1'-0"

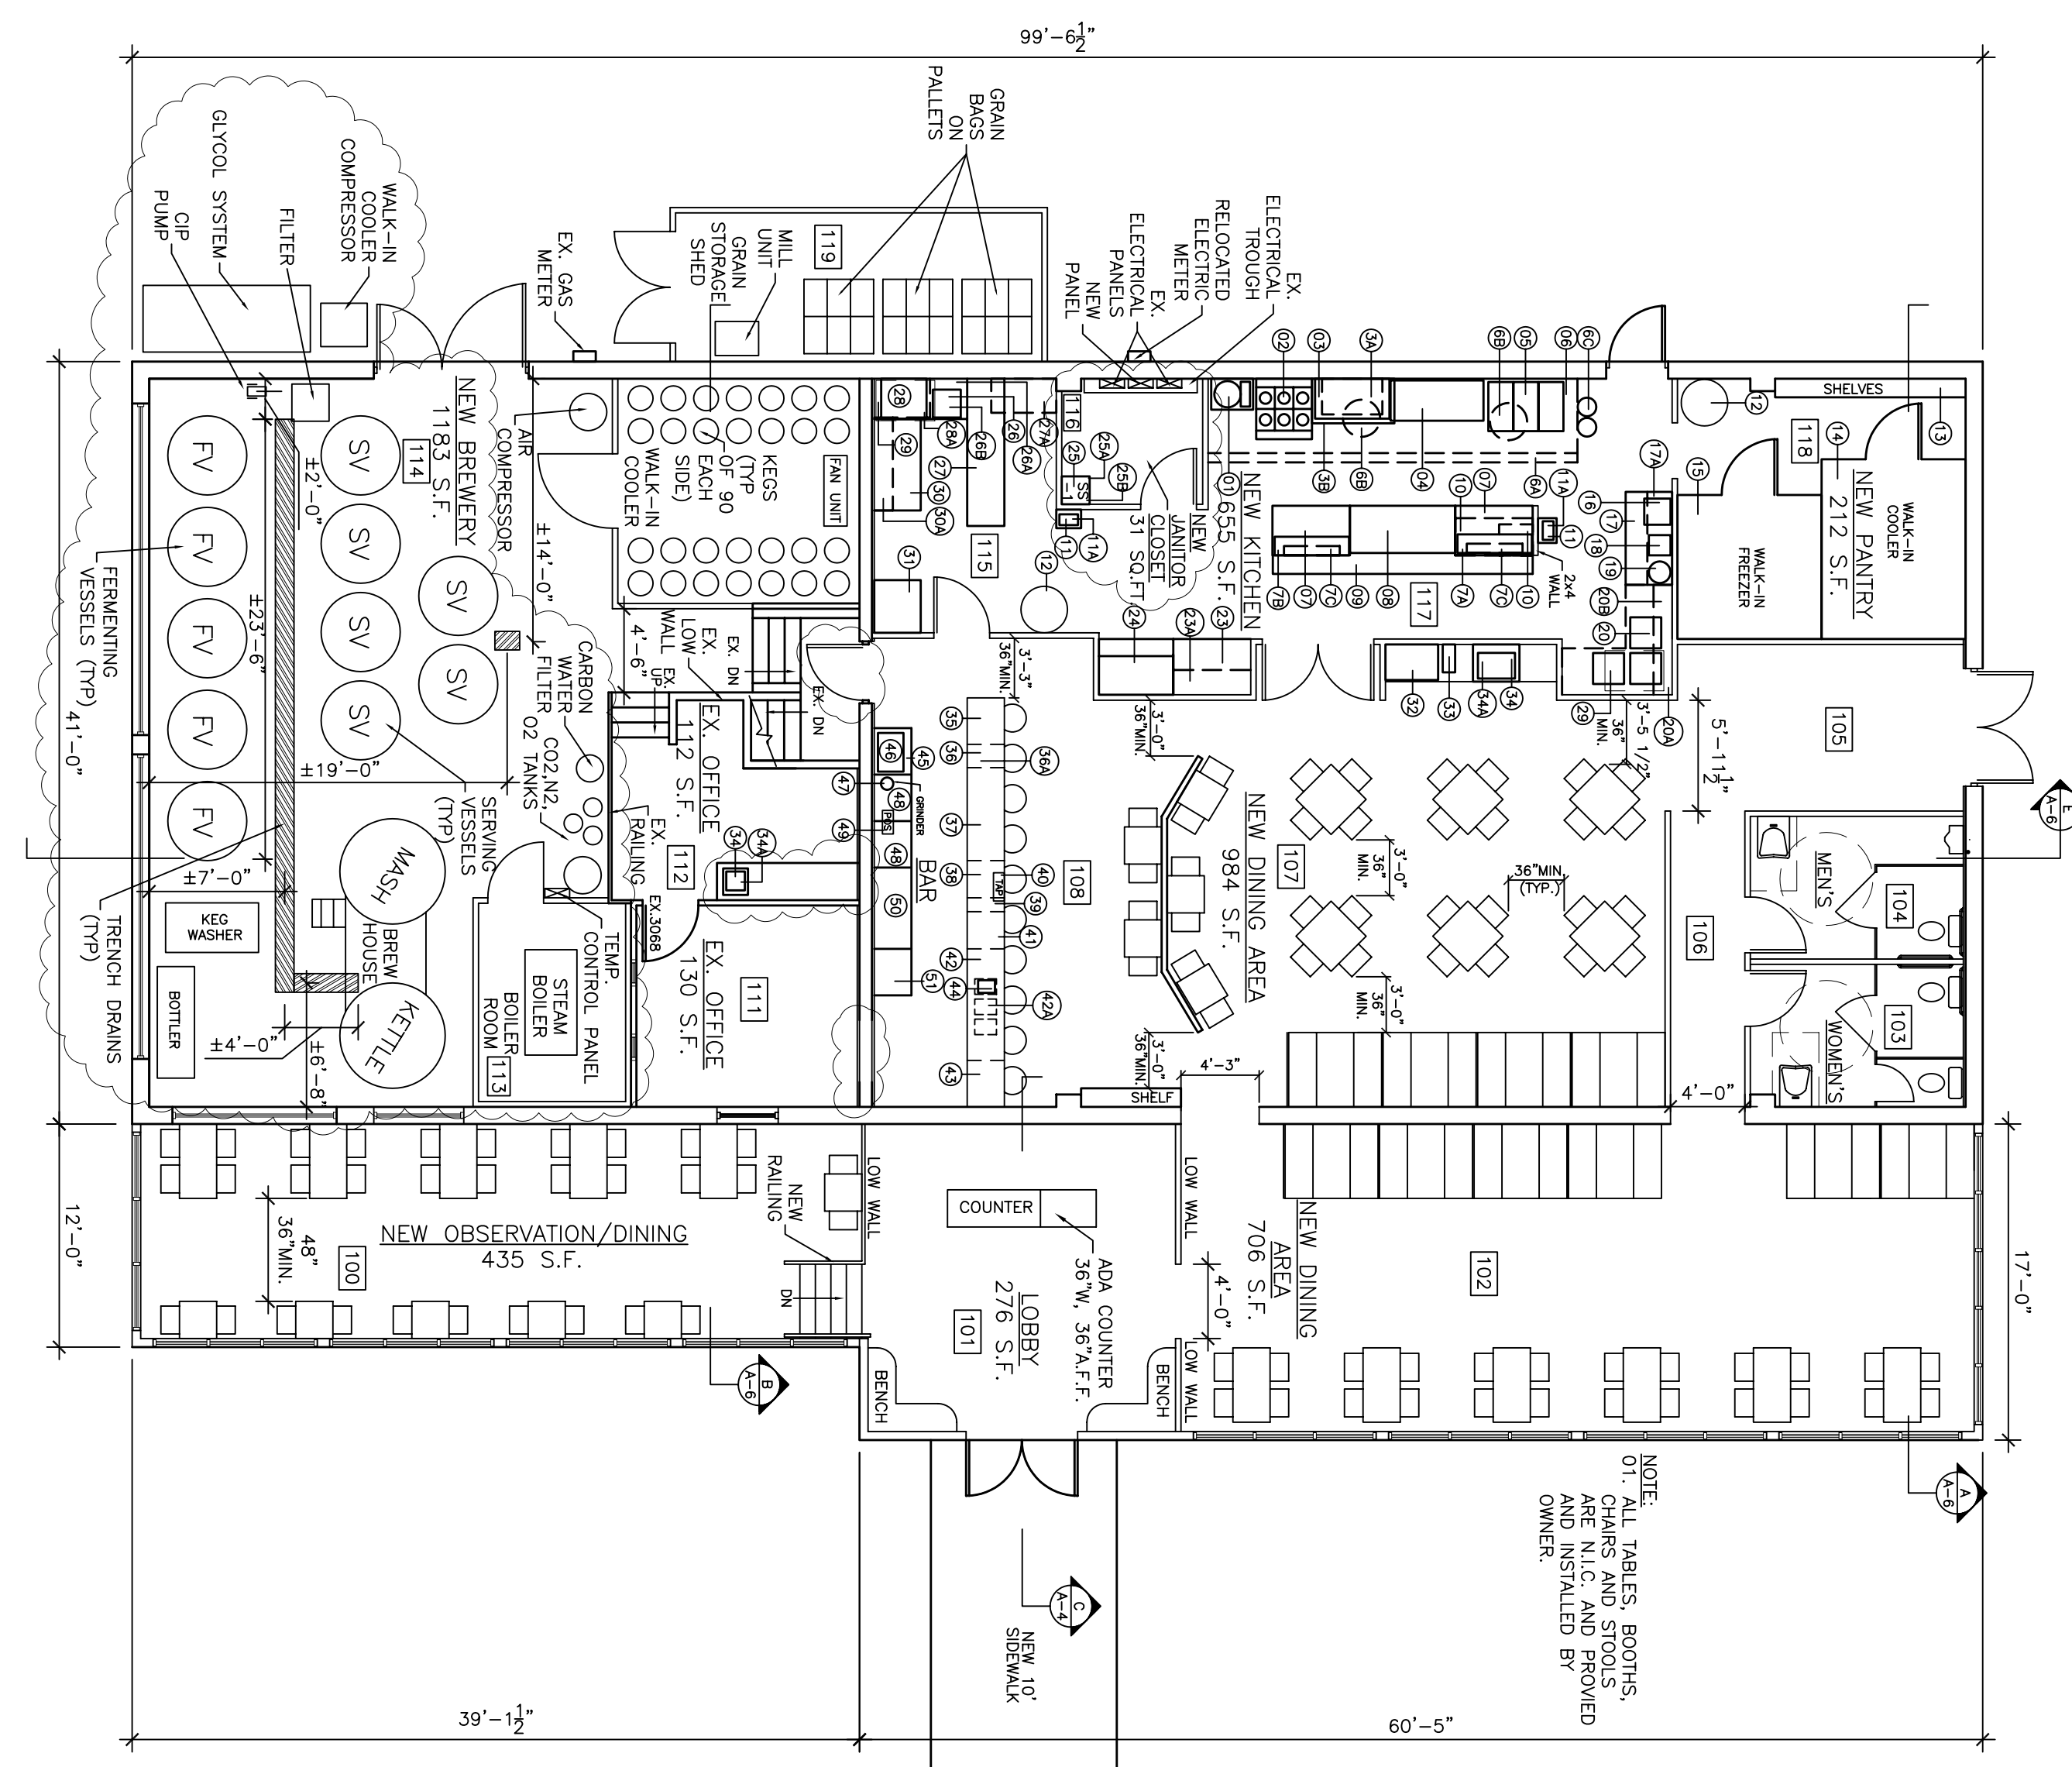

NOTE:
01. ALL TABLES, BOOTHS, CHAIRS AND STOOLS ARE TO BE INSTALLED BY OWNER.